



1 SOG 32 - MECHANICAL PLAN - 5M RESTROOM OPTION (ALTERNATE 'B')

SCALE 3/16" = 1'-0"

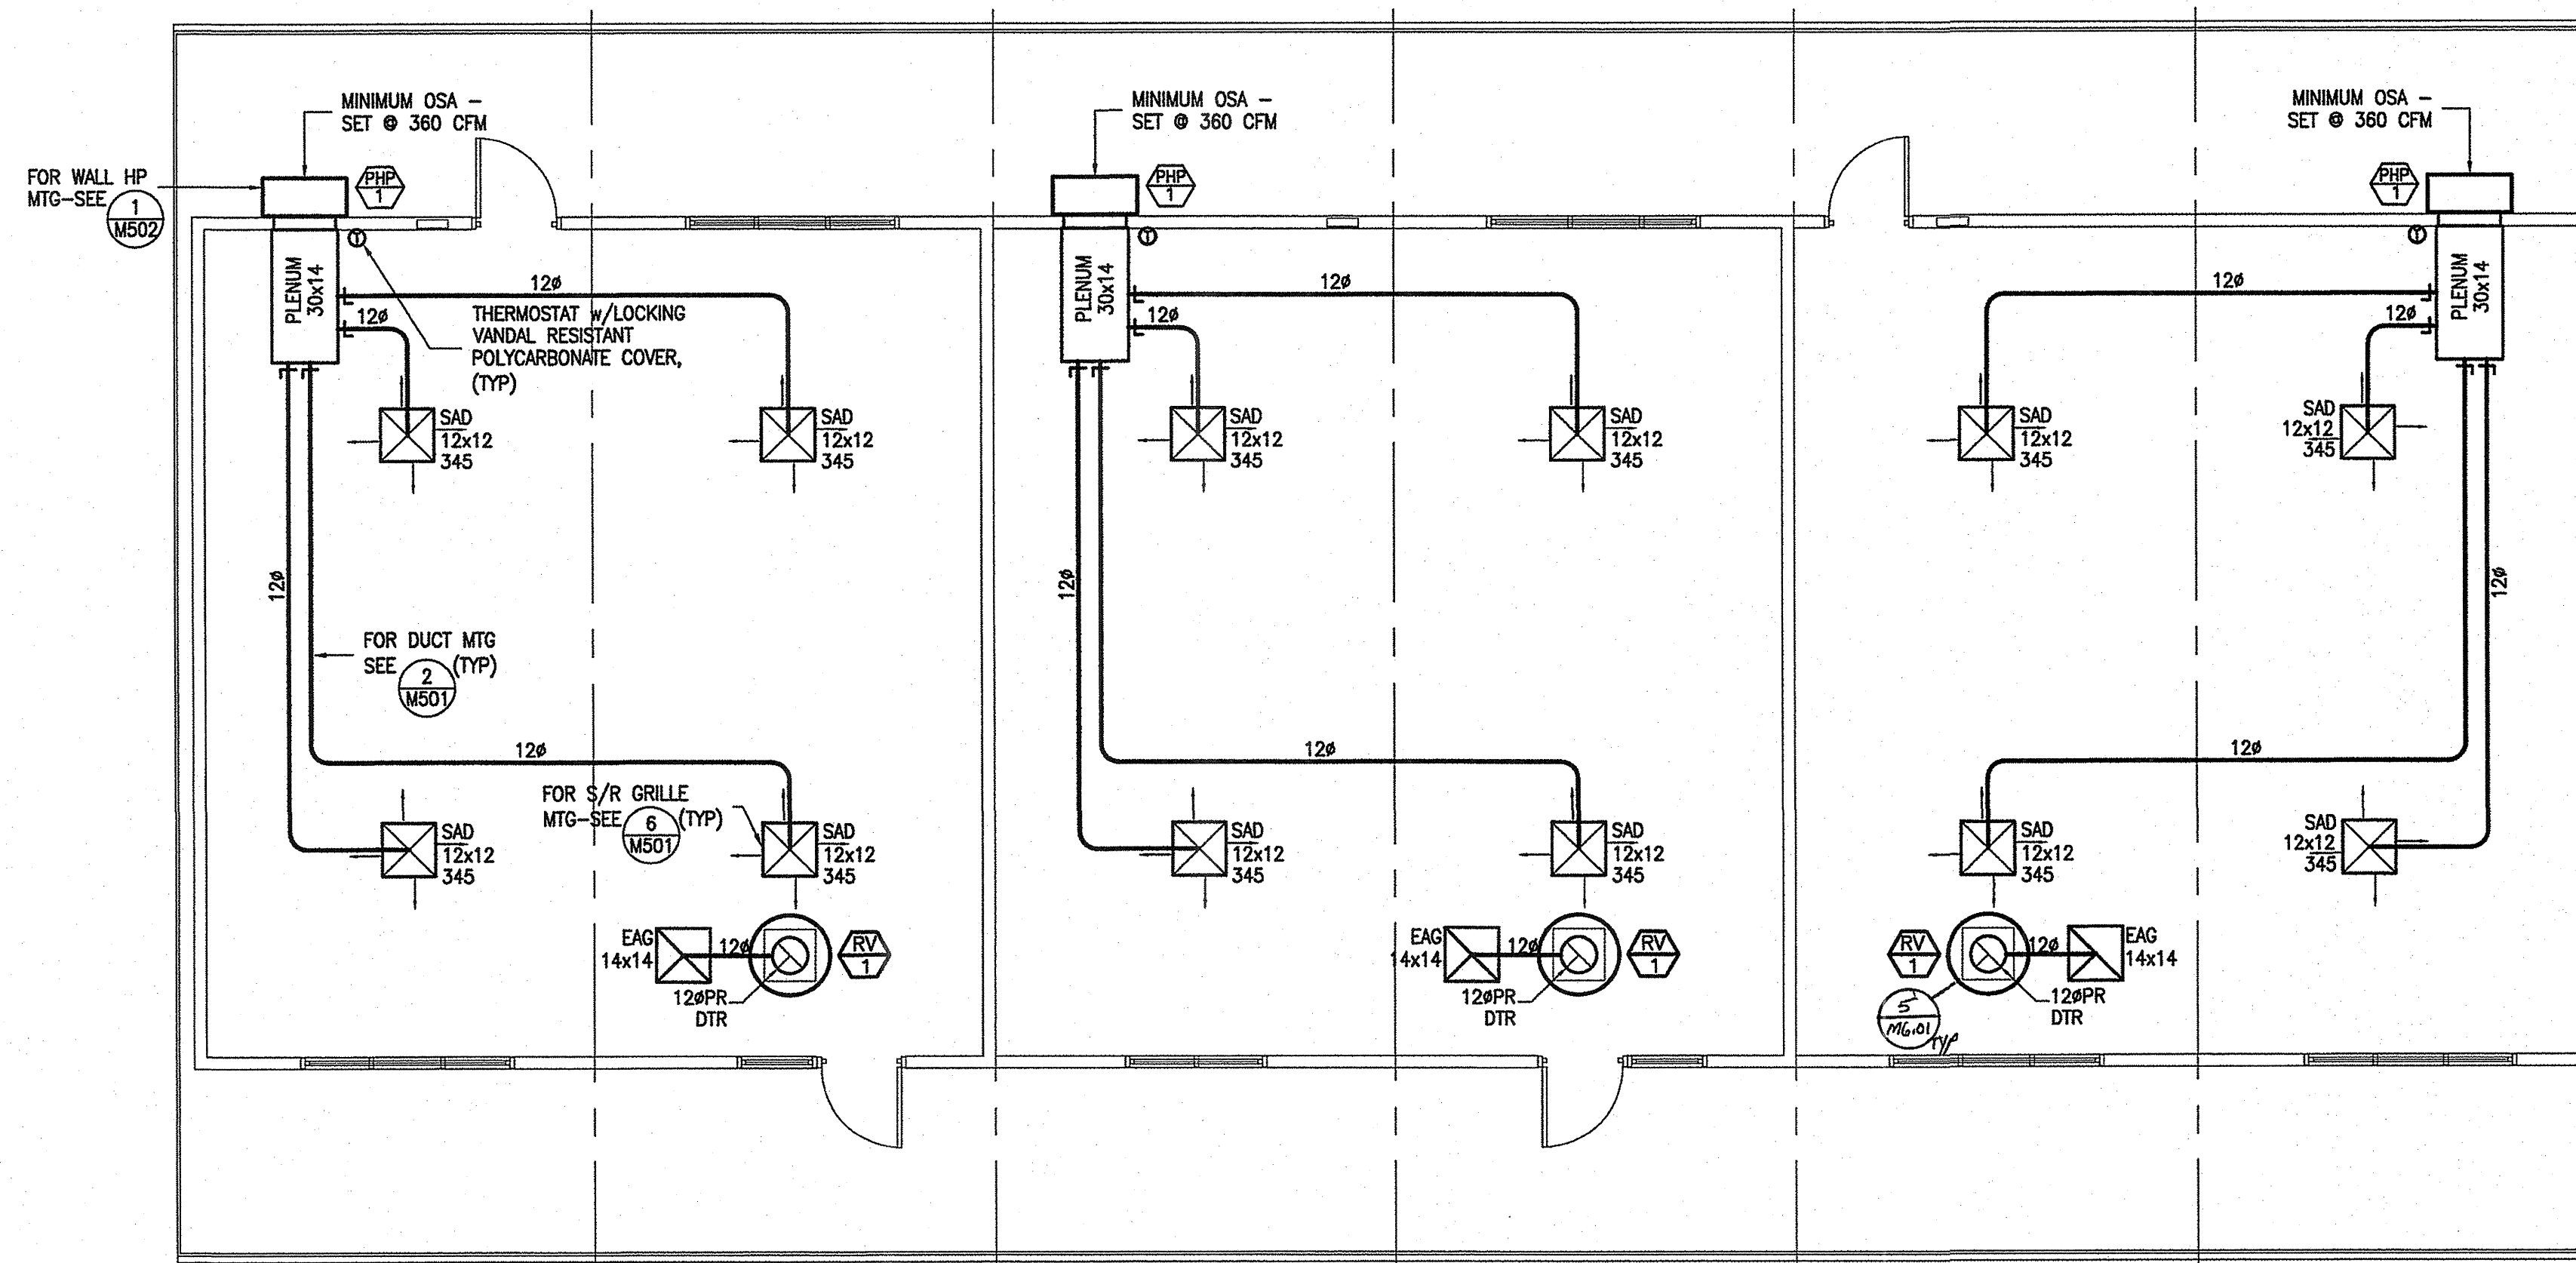

2 SOG 32 - MECHANICAL PLAN - 6M (ALTERNATE 'B')

SCALE 3/16" = 1'-0"

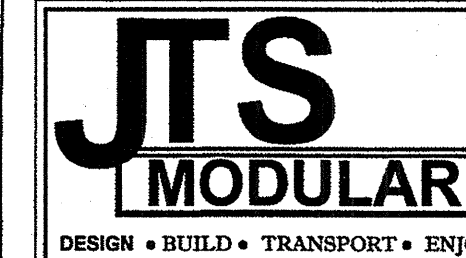

COMMERCIAL
INSTITUTIONAL
AND
RESIDENTIAL
MODULAR
BUILDINGS
DESIGN &
PLANNING

7001 Mc Divitt Dr.
Bakersfield, CA 93313
Office: (661) 835-9270
Plant: (661) 833-2940
Fax: (661) 847-1007
www.jtsmodular.com

LICENSE #21190
CANTELM
ENGINEERING

MECHANICAL & ELECTRICAL
ENGINEERING

1800 21 STREET, SUITE C
BAKERSFIELD, CA 93301
TEL: (661) 324-5252
FAX: (661) 324-8439
Cantelmi@Cantelmi.NET

SOG-32
RE-LOCATABLE
BUILDING PC

APPROVALS

IDENTIFICATION STAMP
DIV. OF THE STATE ARCHITECT
PRE CHECK (PC) DOCUMENT
CODE 2013 CBC
A SEPARATE PROJECT APPLICATION
FOR CONSTRUCTION IS REQUIRED

FILE # PC-32
DATE 3/19/15

DATE _____
PROJECT XX-XXX



02-18-15



SHEET NAME
MECHANICAL PLANS:
5M-RR & 6M
(ALTERNATE 'B')

SHEET NUMBER

M2.02

IDENTIFICATION STAMP
DIV. OF THE STATE ARCHITECT
APP03 117883
AC FLS SS CF
DATE Feb 07 2017